


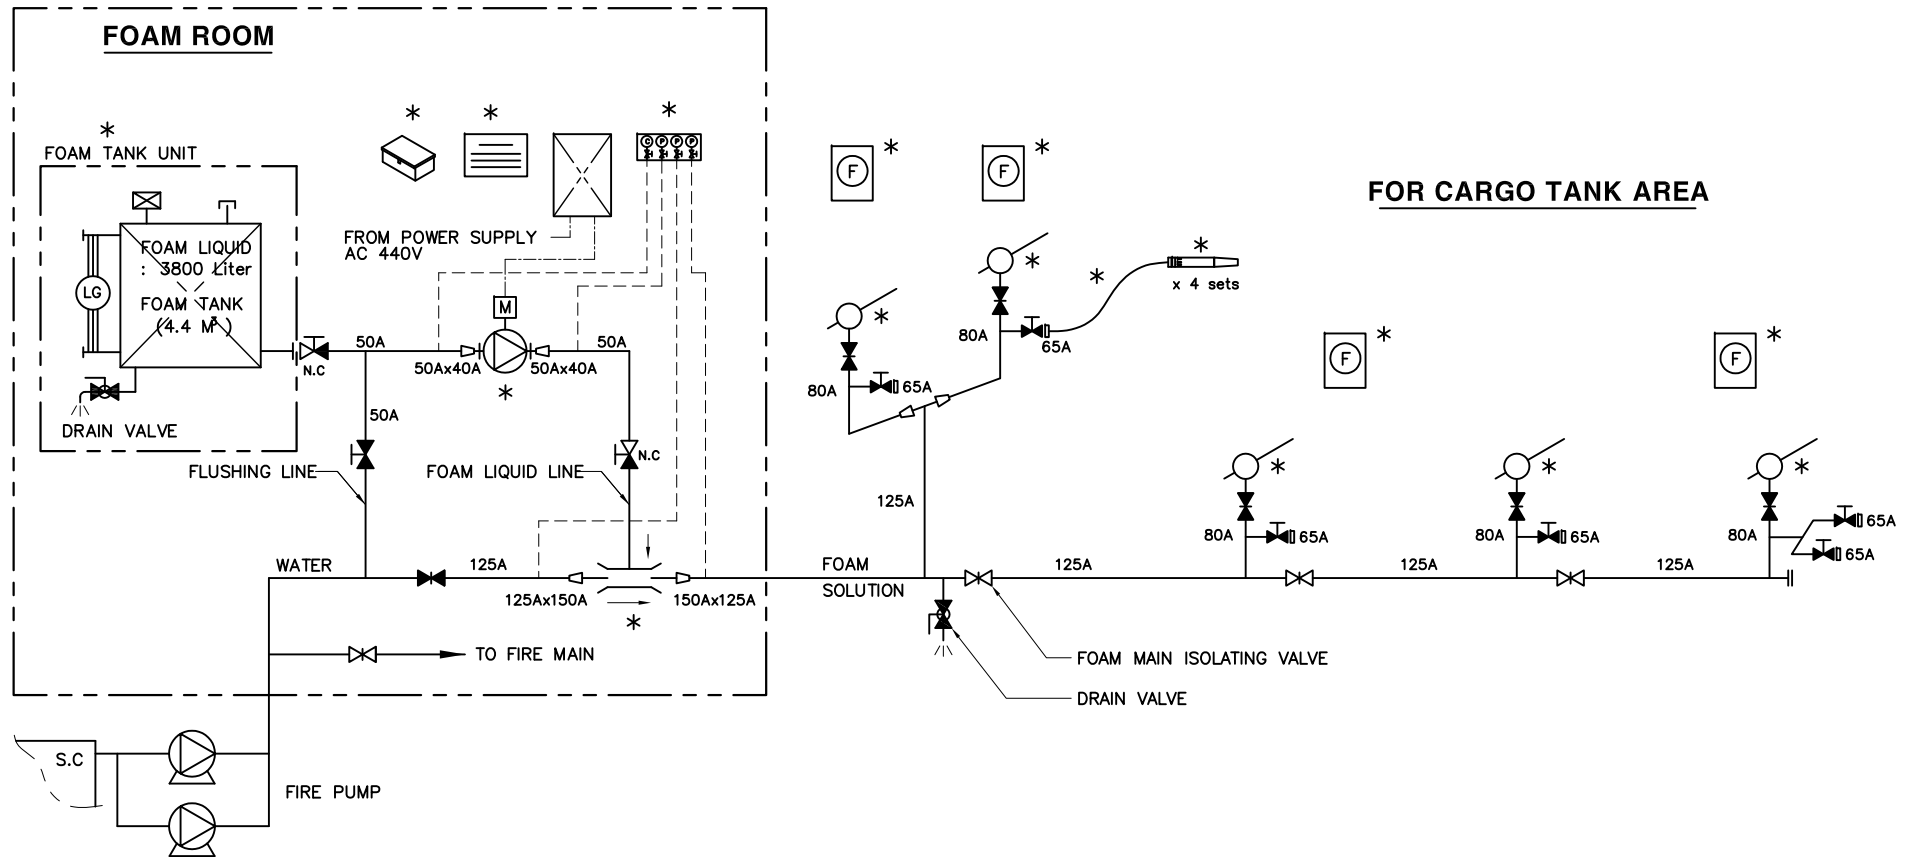

*	MAKER SUPPLY			FILLING CAP (50A)	
	PIPE LINE			BREATH VALVE (65A)	
	ELECTRIC LINE			MANUAL VALVE	
	COPPER TUBE(ø6)			GLOBE CHECK VALVE	
	SPARE PARTS BOX			GATE VALVE	
	MANUAL FOAM MONITOR (F-80)			GAUGE WITH ROOT VALVE	
	FIRE HOSE (65A x 15m)			INSTRUCTION CHART	
	BRANCH PIPE (65A)			LEVEL GAUGE WITH SCALE BOARD	
	FIRE HOSE BOX(INCL. SPANNER, FIRE HOSE, BRANCH PIPE)			PROPORTIONER (50F-150W)	
	REDUCER			FOAM PUMP STARTER (3.0 kW)	
	HYDRANT VALVE			FOAM PUMP (CR10-5)	
	GLOBE VALVE				
	NORMAL CLOSE				
	NORMAL OPEN				
SYMBOL	DESCRIPTION	REMARK	SYMBOL	DESCRIPTION	REMARK

TITLE P & ID		APP. BY	H. NAGAYOSHI
		CHK. BY	H. KUMAZAWA
		DWG. BY	C. H. KANG
		DATE	2005. 05. 06
DWG NO.	FL-0399-03	SCALE : NONE	REV. 01 OF 1
Fine Innovation Fire Protections Pro Tech Co., Ltd.			